

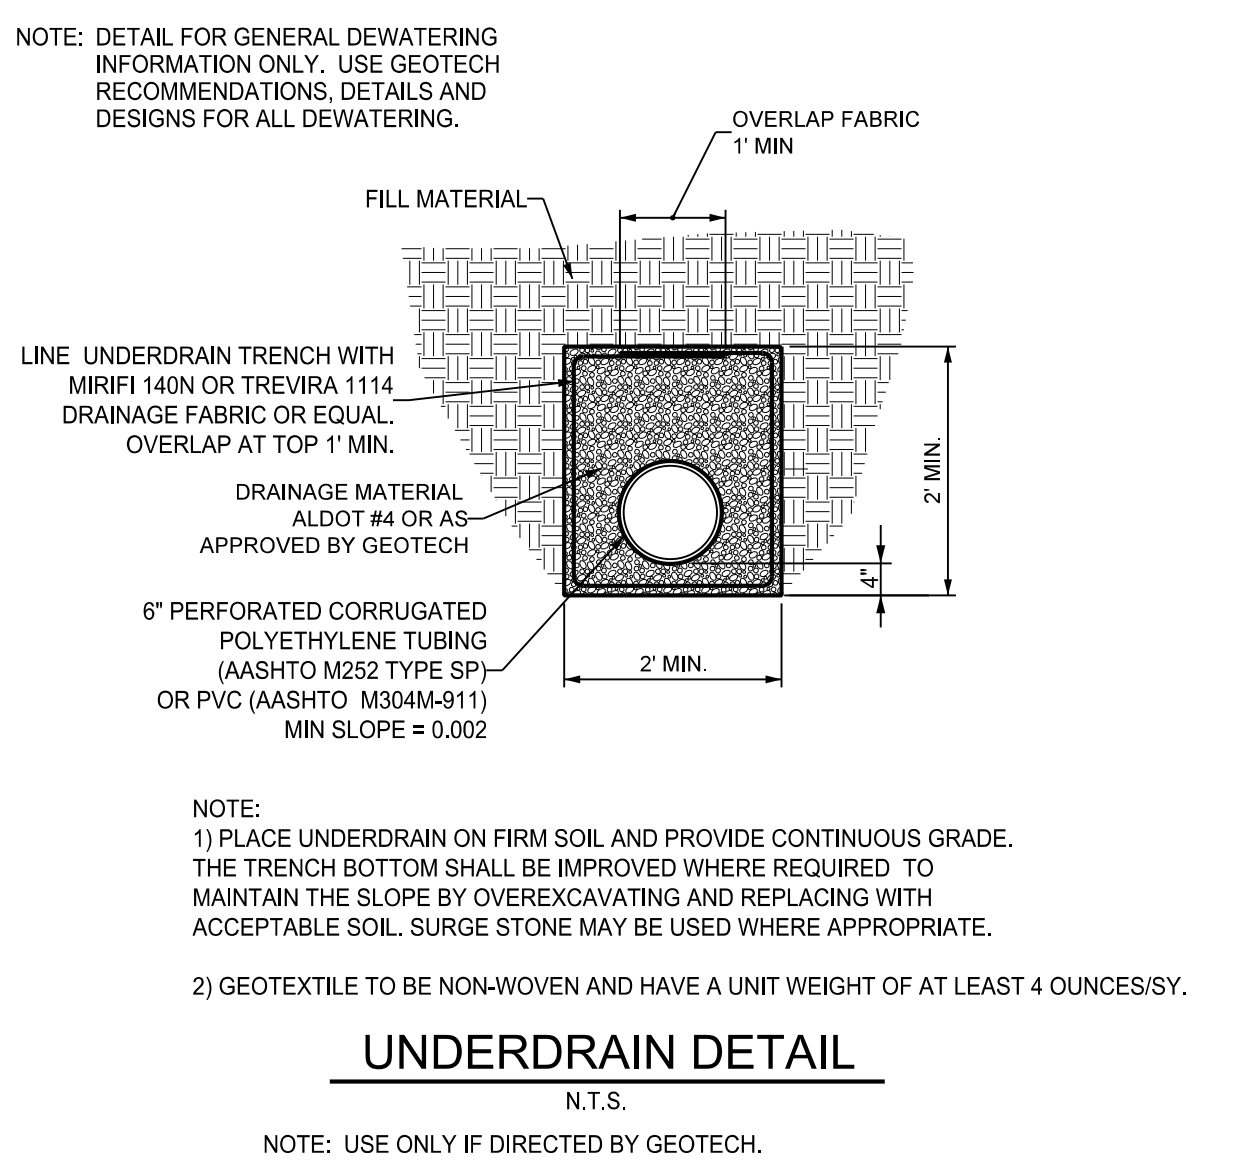
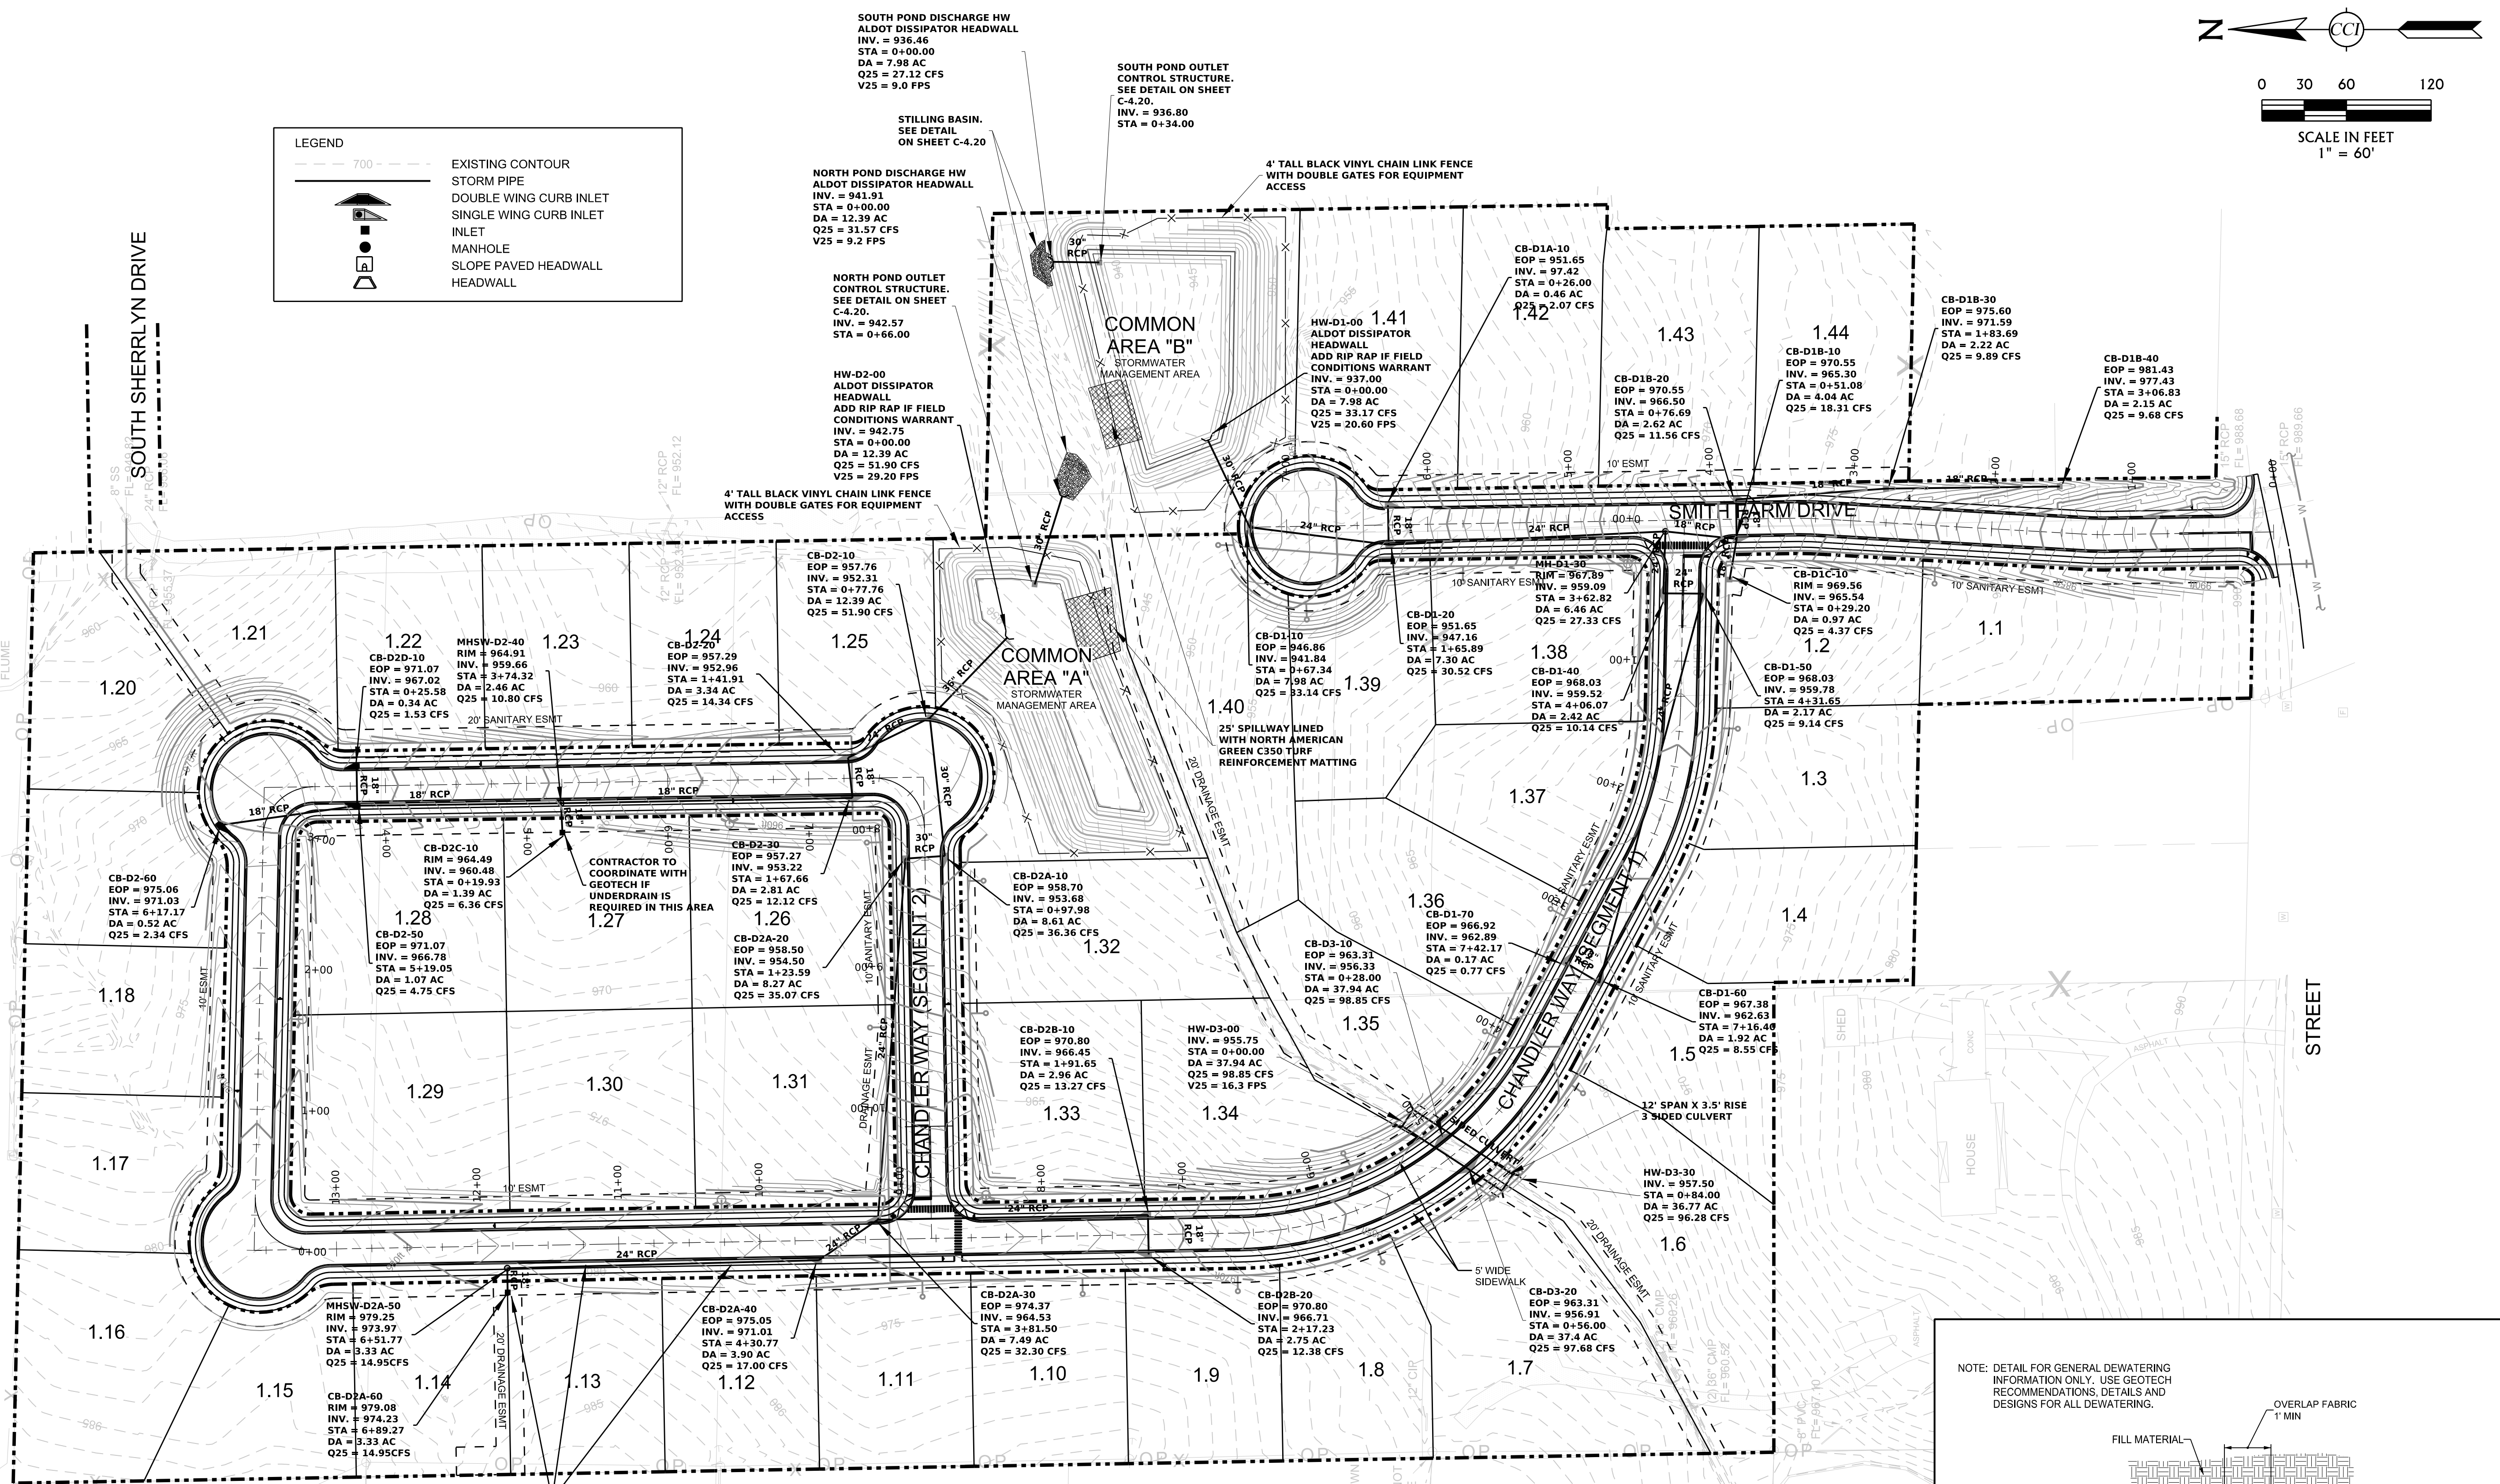


LEGEND

	EXISTING CONTOUR
	STORM PIPE
	DOUBLE WING CURB INLET
	SINGLE WING CURB INLET
	MANHOLE
	SLOPE PAVED HEADWALL
	HEADWALL

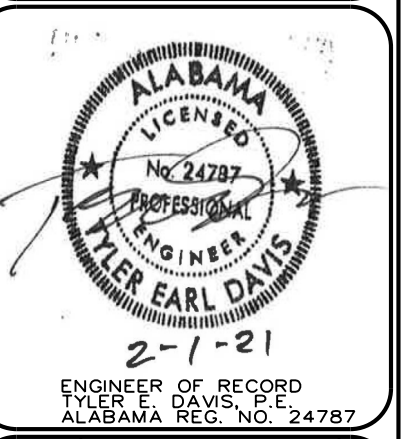

3528 Vann Road
Suite 105
Birmingham, AL 35235
Phone: (205) 665-1991
www.ccope.com

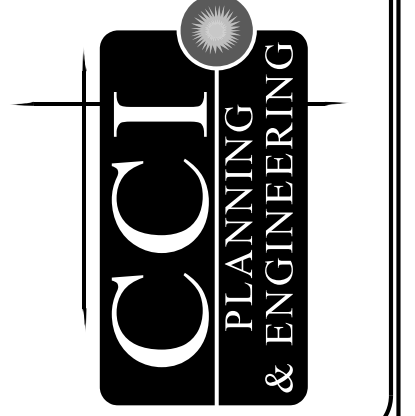

OVERALL DRAINAGE PLAN
SMITH FARM SUBDIVISION
HOOVER, ALABAMA
FOR
CK ENTERPRISES, LLC

DATE:	10/13/2020	PROJECT NO.:	KTCH0001	DRAWN BY:	JEL	CHECKED BY:	TED	SCALE:	1" = 60"
REV. NO.:		REV. DATE:		BY:		CHKD BY:		REVISIONS:	
0				JEL	TED				
SUBMIT FOR CITY APPROVAL									

DRAWING NO. **C-1.00**